

RL
DESIGN
858 Washington St.
Suite 312
Dedham, MA, 02026
508.404.8421
401davinci@gmail.com

AUBURN INDUSTRIAL SERVICES
103 MILLBURY STREET, AUBURN, MA.

EXISTING CONDITIONS FLOOR PLAN

REVISIONS:

DATE :
1-22-2018


LEVEL

FILE :

SCALE:
3/16" = 1'-0"

DRAWING No.

A-1

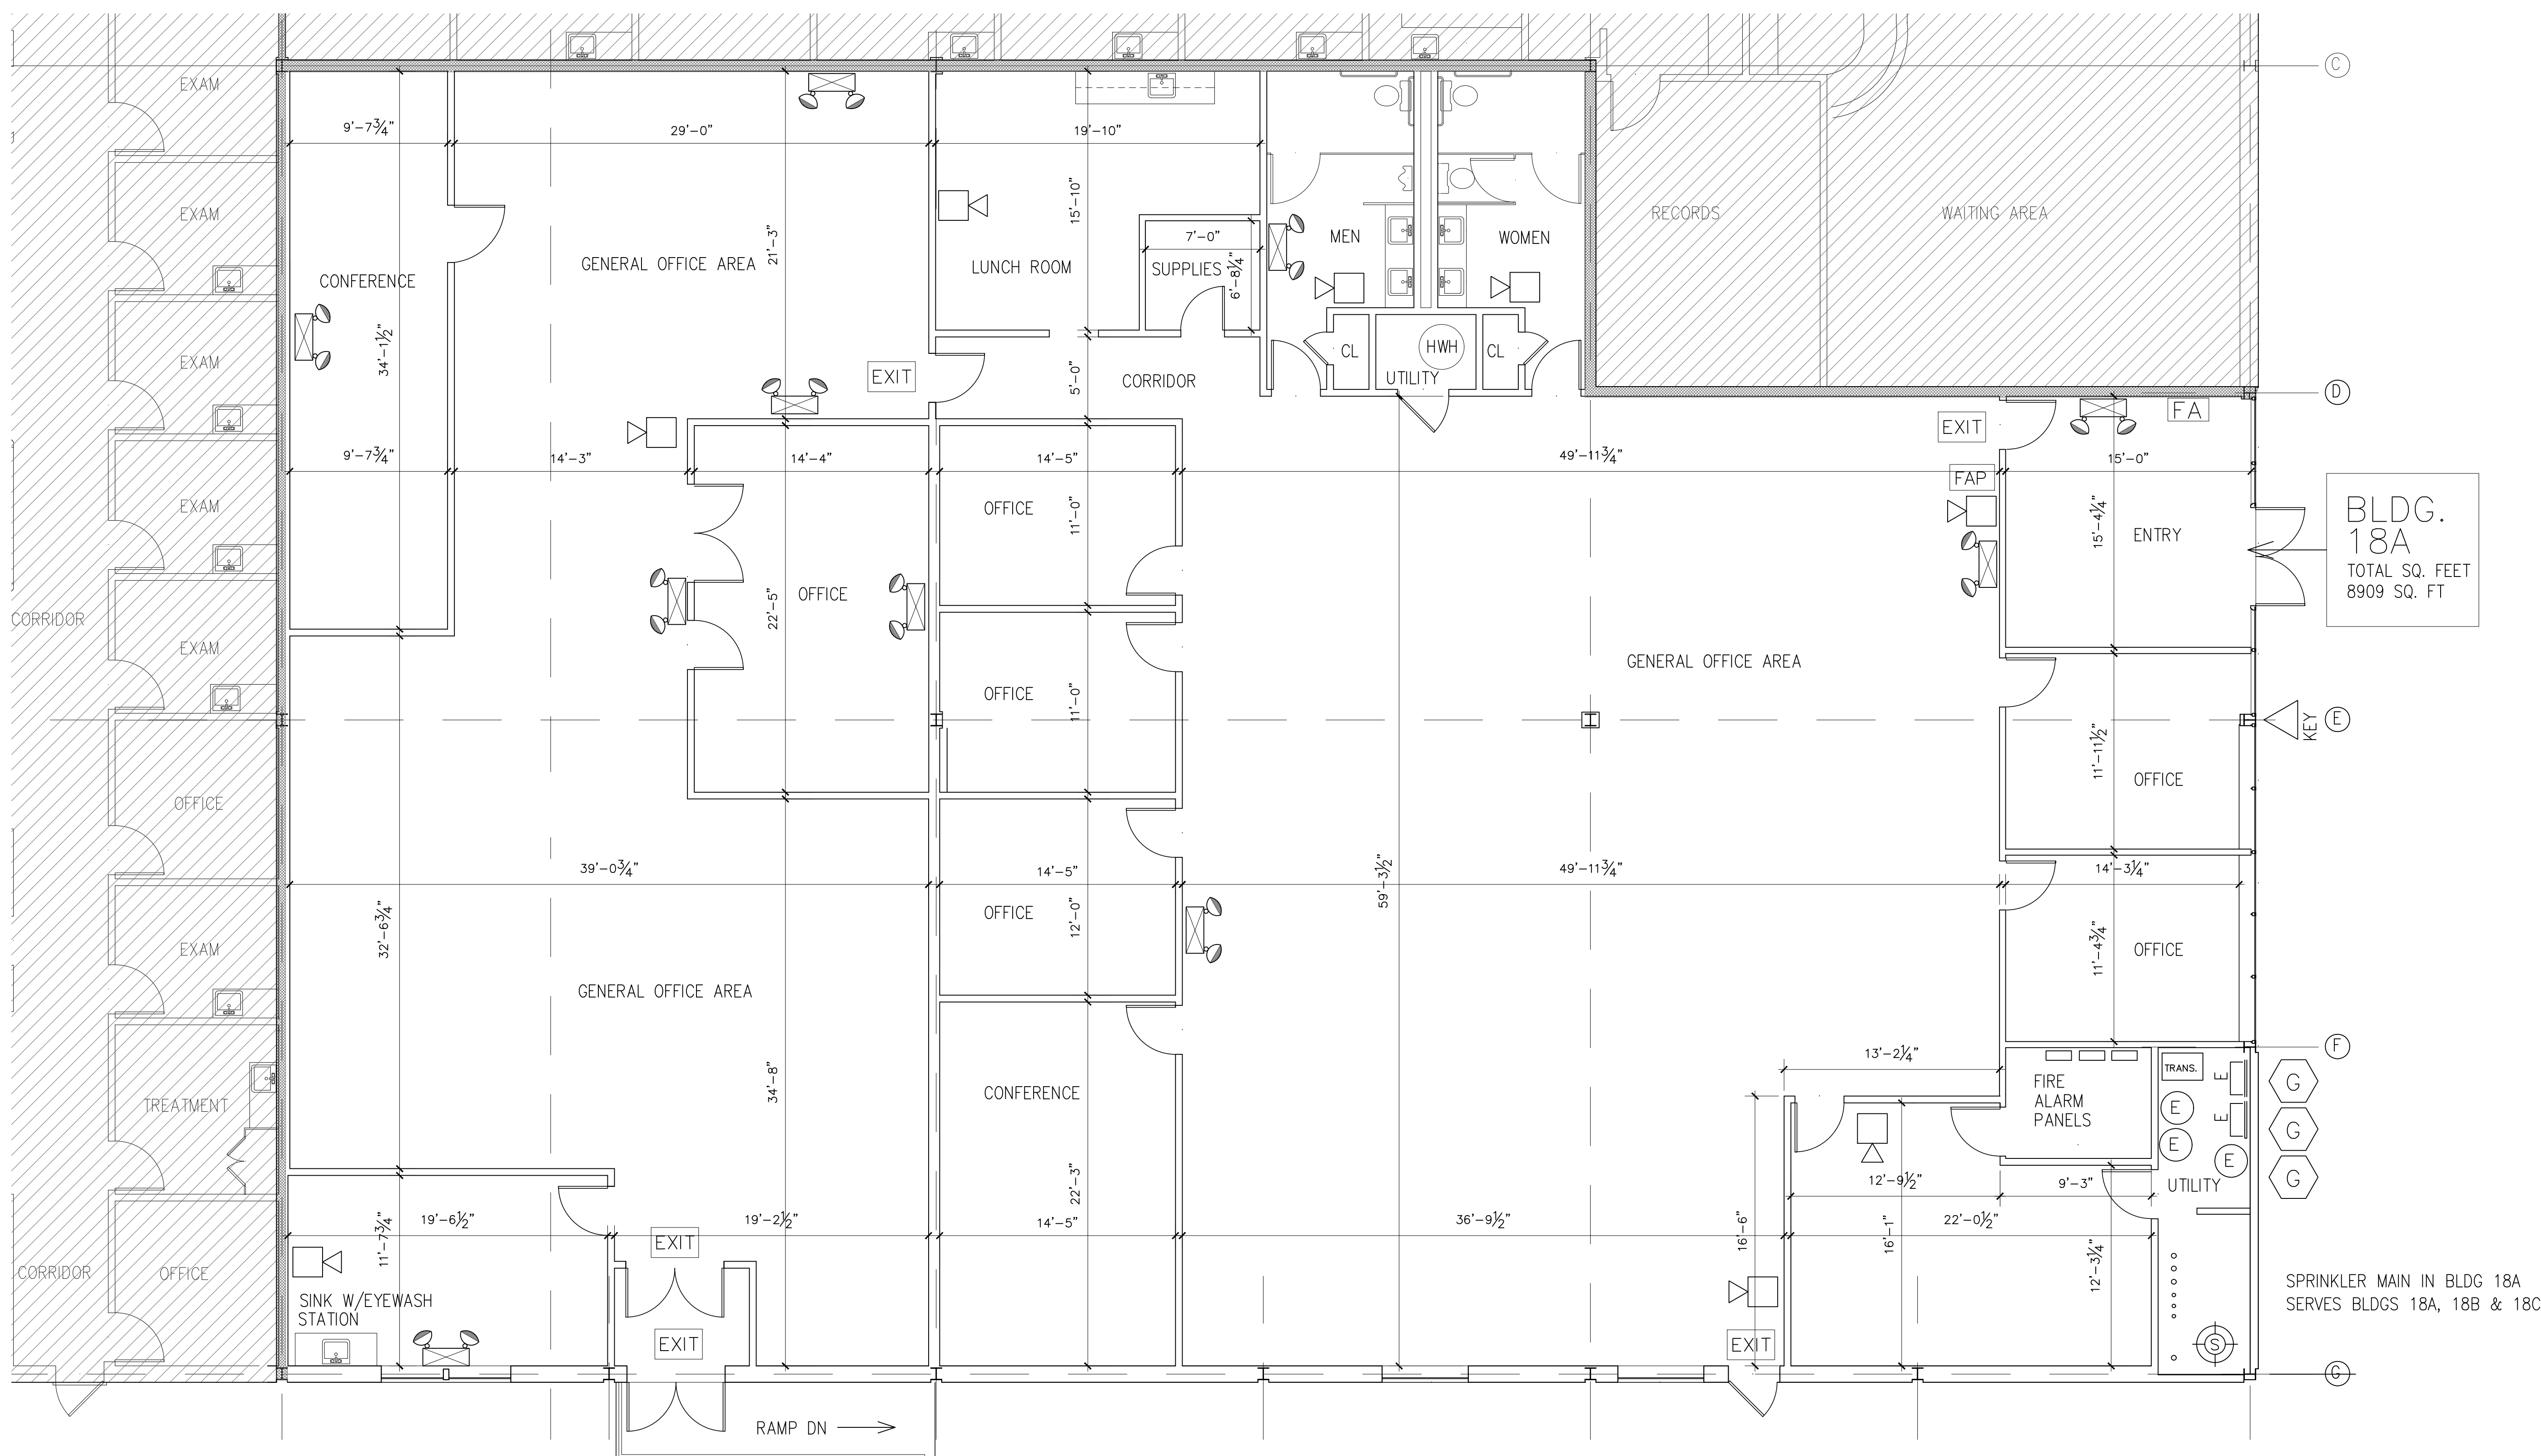

BLDG.
18A
TOTAL SQ. FEET
8909 SQ. FT

SPRINKLER MAIN IN BLDG 18A
SERVES BLDGS 18A, 18B & 18C

BLDG 18A TOTAL AREA	=	8909 SQ. FT.
TOTAL BUILDING FOOTPRINT	=	24,479 SQ. FT.

DIMENSIONS ON PLAN ARE FINISH WALL TO FINISH WALL SURFACES

FIRE SAFETY APPARATUS LEGEND	
	DUAL LIGHT EXIT/EMERGENCY LIGHTING UNIT WITH BATTERY BACK-UP.
	DUAL LIGHT EMERGENCY LIGHTING UNIT WITH BATTERY BACK-UP.
	HORN & STROBE
	STROBE LIGHT
	OVERHEAD ILLUMINATED EMERGENCY EXIT LIGHT WITH BATTERY BACKUP INDICATING EMERGENCY EXIT LOCATIONS
	FIRE ANUNCIATOR PANEL
	FIRE ALARM PULL STATION

LEGEND-SYMBOLS			
	ELEC. BREAKER BOX		SPRINKLER MAIN
	ELEC. METER		KEY
	GAS METER		