


1 BUILDING #16 SECOND FLOOR PLAN  
SCALE: 1/8" = 1'-0"

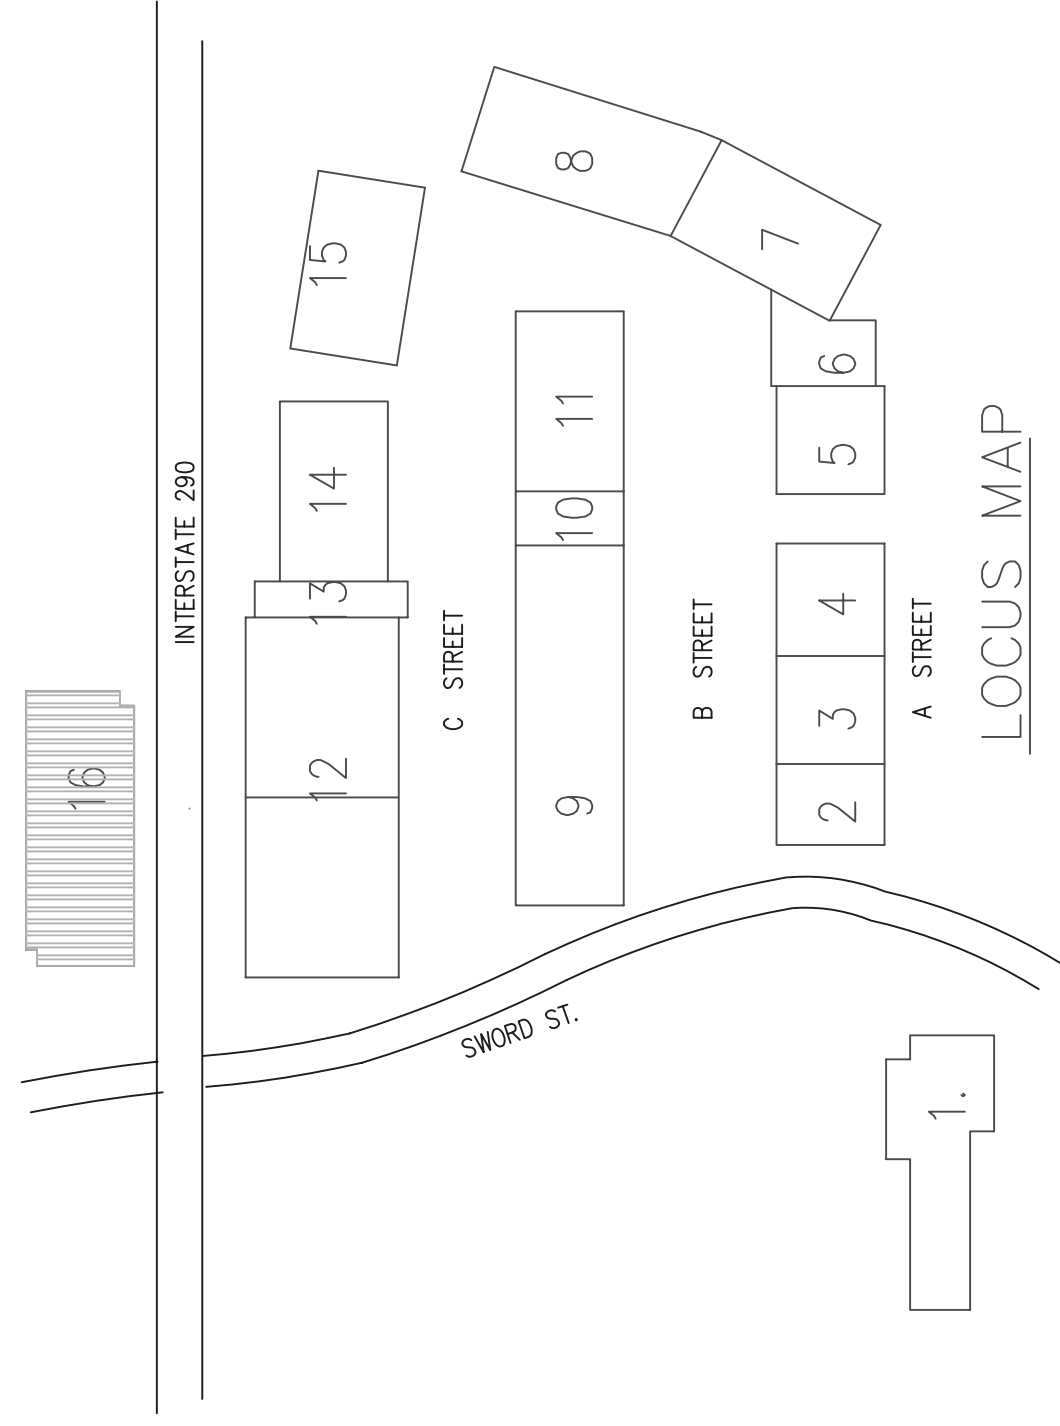

LEGEND-SYMBOLS	
	ELEC. BREAKER BOX
	ELEC. METER
	GAS METER
	SPRINKLER MAIN
	KNOCK BOX
	KEY

	AUBURN INDUSTRIAL PARK, AUBURN, MA.
	BUILDING #16 2ND FLR. PLAN
	DATE : 15 APRIL 2009 SCALE: 1/8" = 1'-0"
	A-2